


# USP MSP Campus - Data Conduit Layout 2018

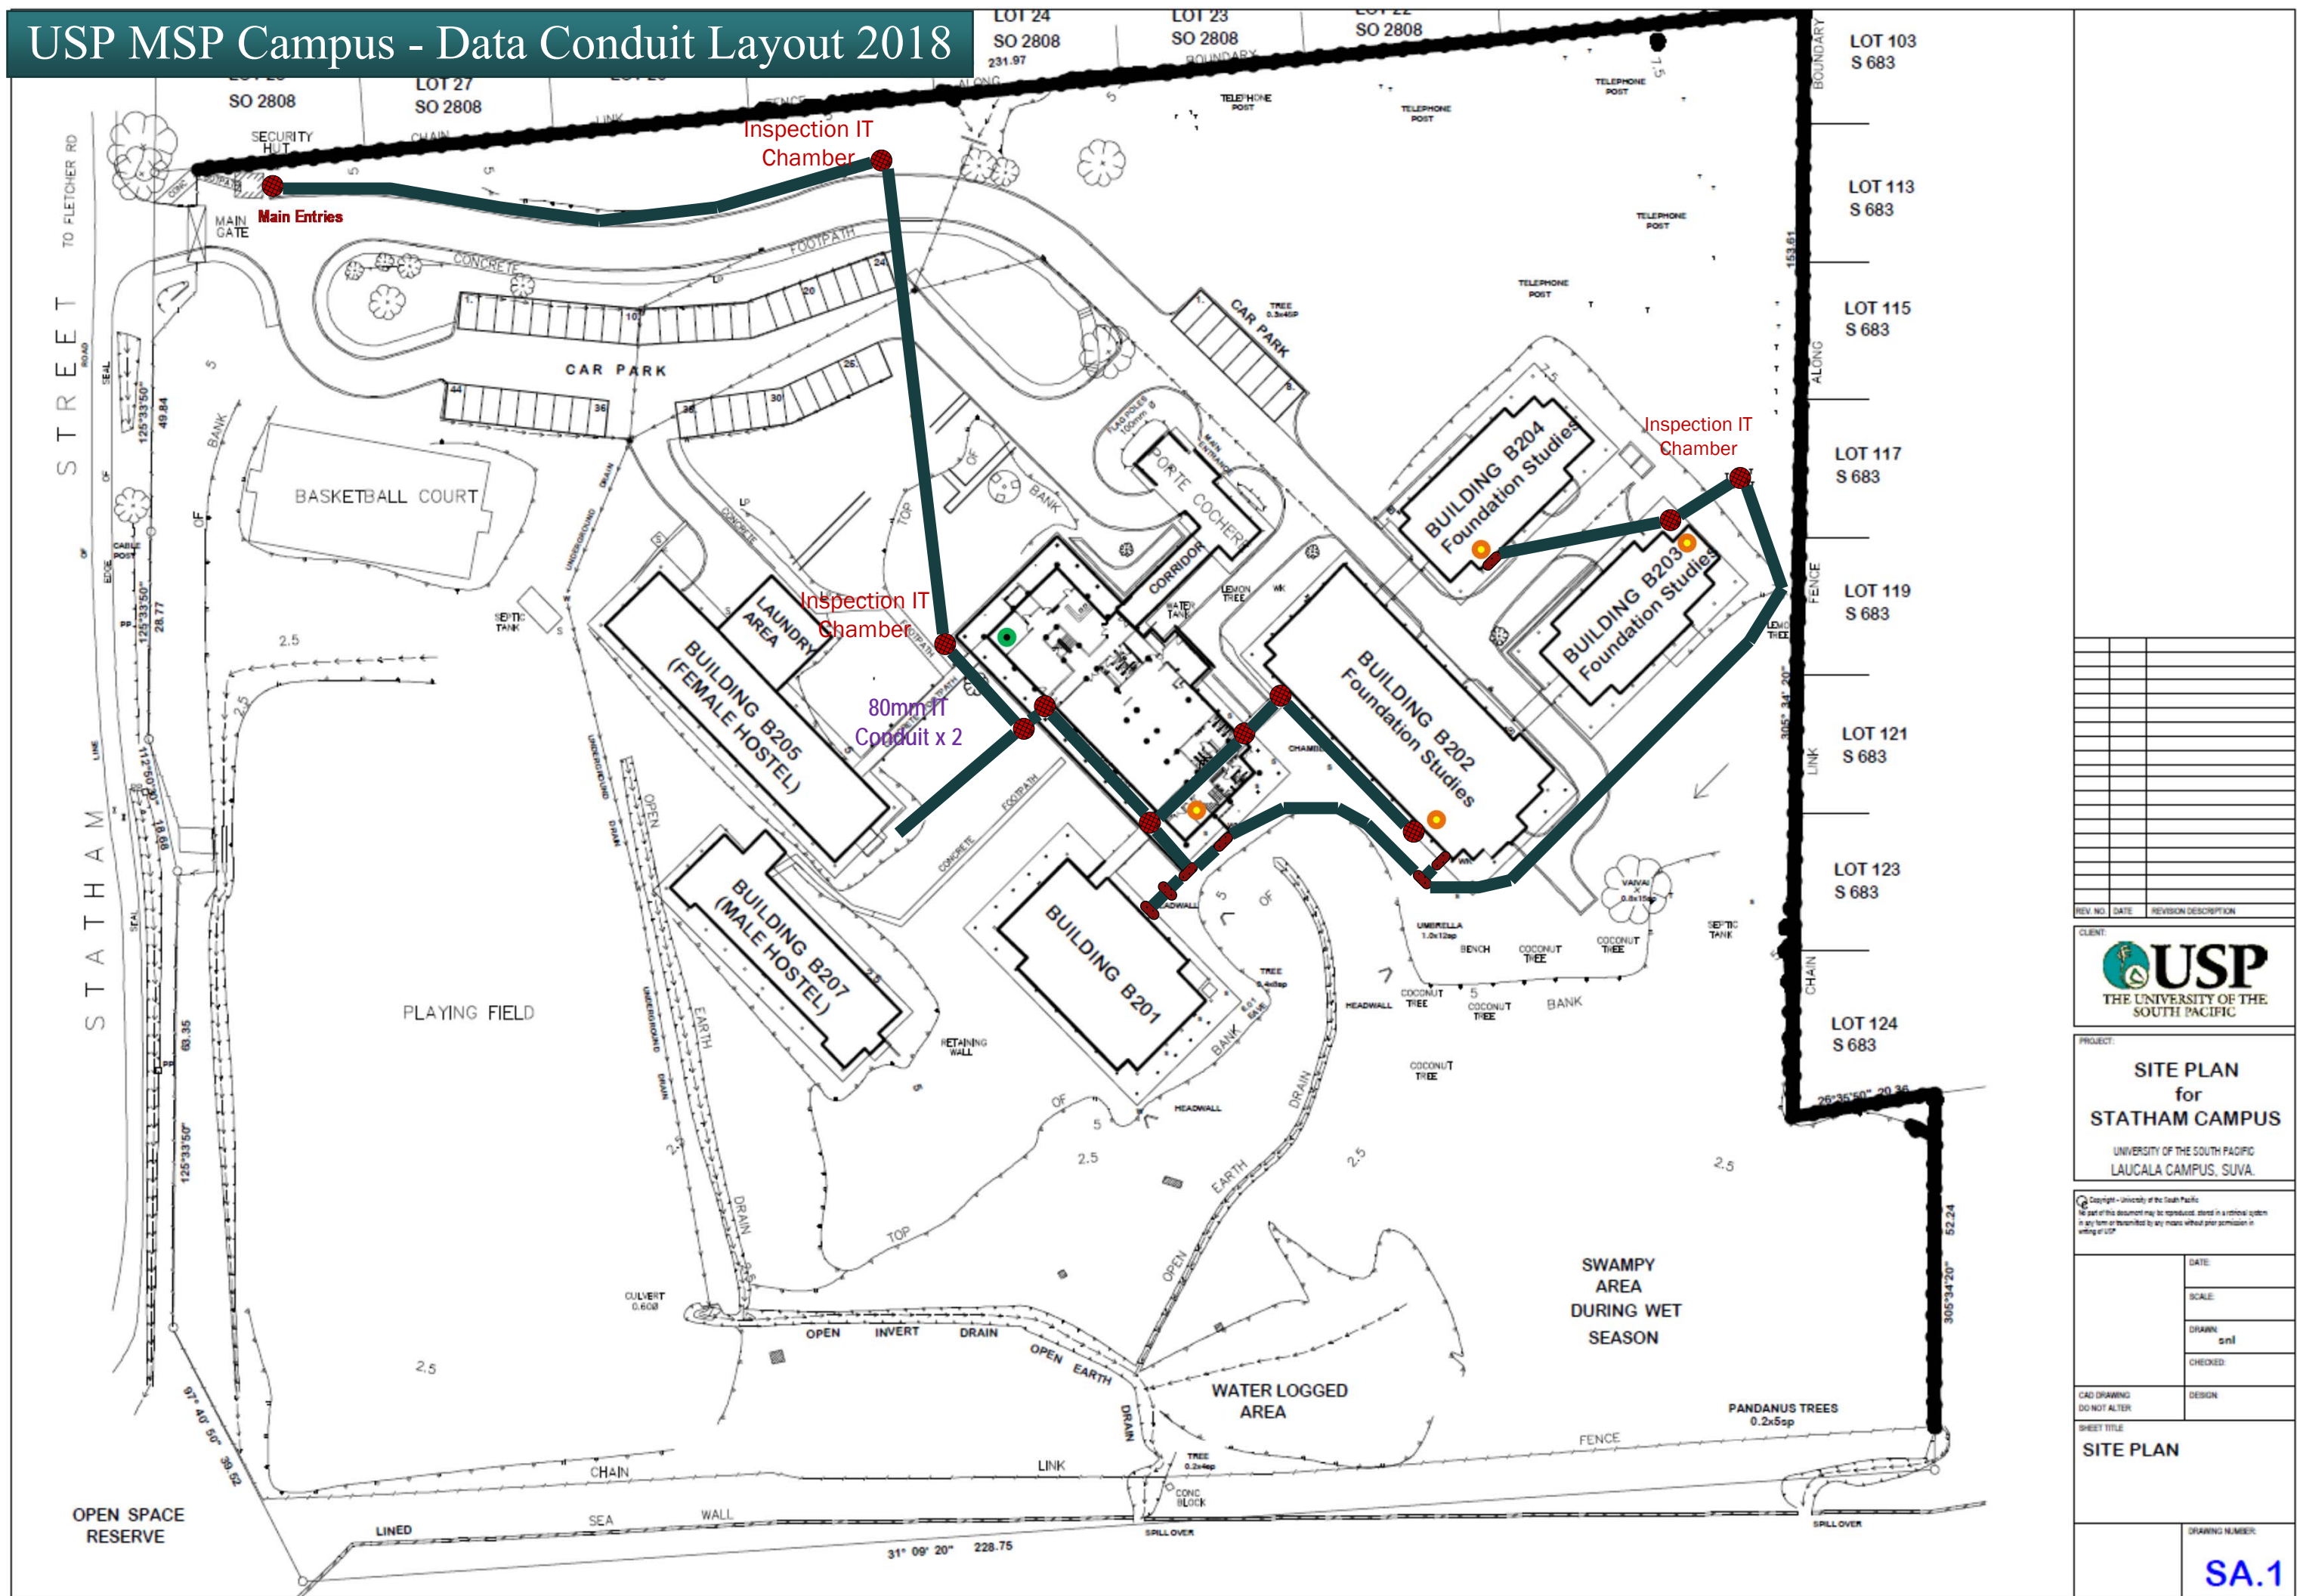

REV. NO.	DATE	REVISION DESCRIPTION

CLIENT:

THE UNIVERSITY OF THE SOUTH PACIFIC

PROJECT:

**SITE PLAN  
for  
STATHAM CAMPUS**

UNIVERSITY OF THE SOUTH PACIFIC  
LAUCALA CAMPUS, SUVA.

Copyright - University of the South Pacific  
No part of this document may be reproduced, stored in a retrieval system or in any form or transmitted by any means without prior permission in writing of USP.

DATE:	
SCALE:	
DRAWN:	snl
CHECKED:	
CAD DRAWING DO NOT ALTER:	DESIGN

SHEET TITLE

**SITE PLAN**

DRAWING NUMBER:

**SA.1**